

Addendum 02

DOCUMENT 00 9100

DATE: February 23, 2024

PROJECT: EACS New Haven Primary, Leo Elementary and Cedarville Lighting Replacement
1445 Berwick Lane, New Haven, Indiana 46774 (New Haven)/
14811 Wayne Street, Leo, Indiana 46765 (Leo)/
12225 Hardisty Rd, Fort Wayne, Indiana 46845 (Cedarville)

PROJECT #: 23085.00

OWNER: East Allen County Schools
Contact: Chris Baker
1322 Green Road
New Haven, Indiana 46774

ARCHITECT: Garmann Miller
38 South Lincoln Drive
P.O. Box 71
Minster, Ohio 45865

TO: Prospective Bidders

This addendum form is a part of the Contract Documents and modifies the Bidding Documents dated February 7, 2024, with amendments and additions noted below.

Acknowledge receipt of this Addendum on the Bid Form. Failure to do so may disqualify the Bidder.

This addendum consists of 2 pages and 2 re-issued drawing sheets.

CHANGES TO THE DRAWINGS

1. Drawing Sheet A2.1 New Haven – First Floor Reflected Ceiling Plan – Unit A: Detail 1
New Haven First Floor Reflected Ceiling Plan – Unit A: Alternate #2: New ceiling grid shall be 2' x 4' in lieu of 2' x 2'.
2. Drawing Sheet A2.3 New Haven – First Floor Reflected Ceiling Plan – Unit C: Detail 1
New Haven First Floor Reflected Ceiling Plan – Unit C: Alternate #2: New ceiling grid shall be 2' x 4' in lieu of 2' x 2'.



ATTACHMENTS

The following attachments are included and are part of this addendum:

Drawing Sheets A2.1 and A2.3.

END OF ADDENDUM



EACS NEW HAVEN PRIMARY, LEO ELEMENTARY AND
CEDARVILLE LIGHTING REPLACEMENT


1405 BERNICK LANE, NEW HAVEN, INDIANA 46774 (NEW HAVEN) / 4611 WAYNE STREET, LEO, INDIANA 46755 (LEO) / 12325 HARBODY RD, FORT WAYNE, INDIANA 46845 (CEDARVILLE)

ISSUANCES/REVISIONS		
PROJECT NUMBER:	BID DOCUMENTS	02/07/2024
1	ADDENDUM #2	02/23/2024

PROJECT NUMBER:	DRAWN BY:	CHECKED BY:
23085.00	RLS	KCR

SHEET TITLE:
**NEW HAVEN - FIRST
FLOOR REFLECTED
CEILING PLAN - UNIT A**

SHEET NUMBER:
A2.1

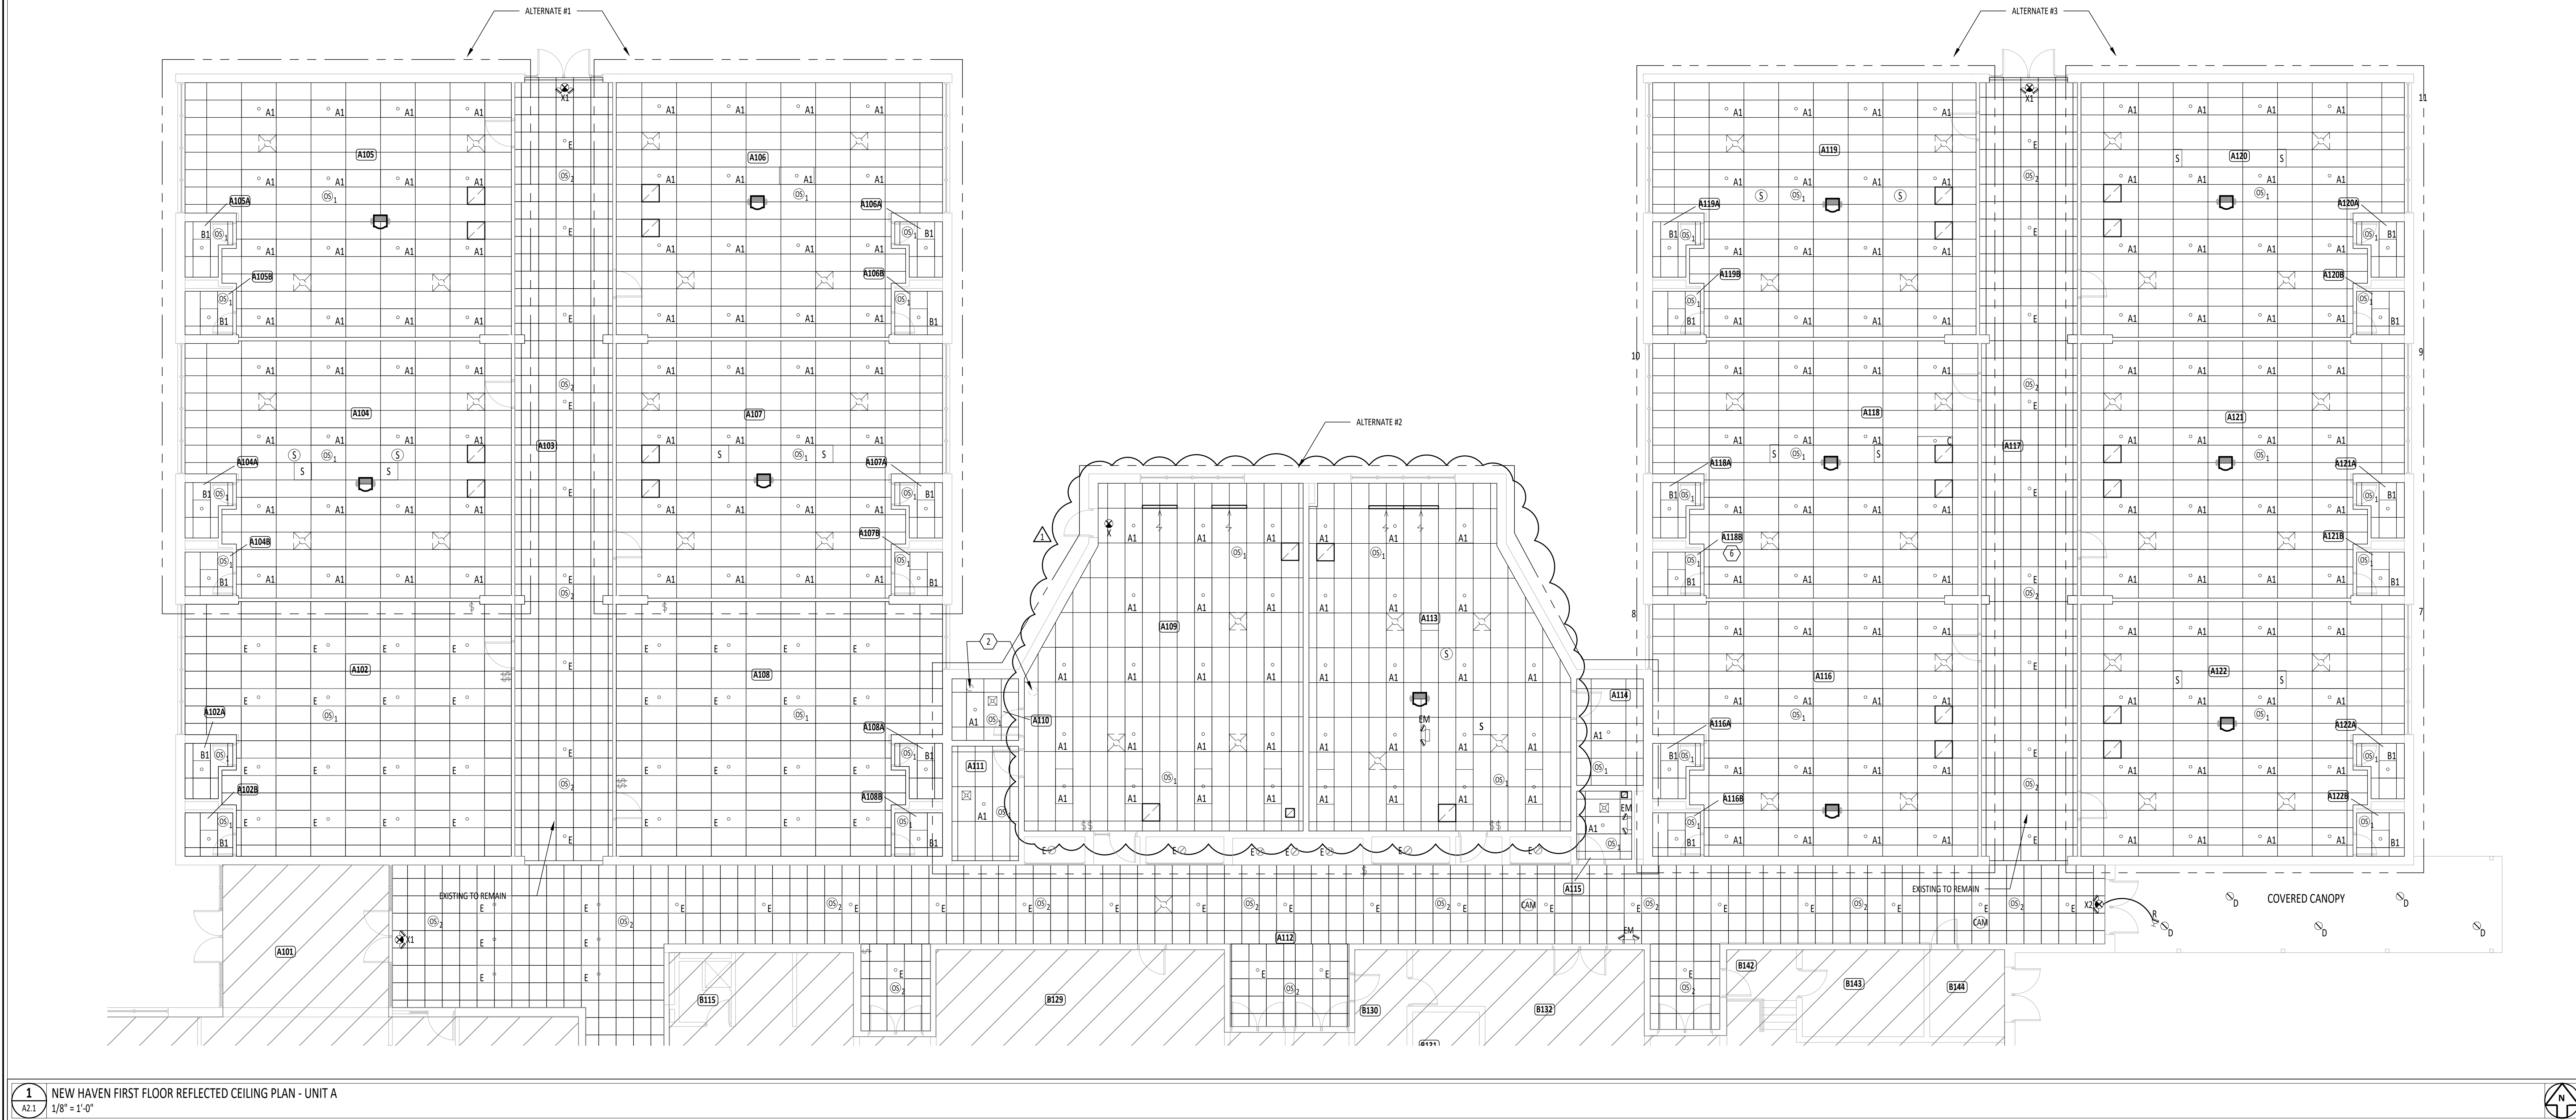

1 NEW HAVEN FIRST FLOOR REFLECTED CEILING PLAN - UNIT A
1/8" = 1'-0"

ROOM INDEX-UNIT A	
ROOM NUMBER	ROOM NAME
A101	VESTIBULE
A102	CLASSROOM
A102A	GIRLS RESTROOM
A102B	BOYS RESTROOM
A103	CORRIDOR
A104	CLASSROOM
A104A	GIRLS RESTROOM
A104B	BOYS RESTROOM
A105	CLASSROOM
A105A	GIRLS RESTROOM
A105B	BOYS RESTROOM
A106	CLASSROOM
A106A	GIRLS RESTROOM
A106B	BOYS RESTROOM
A107	CLASSROOM
A107A	GIRLS RESTROOM
A107B	BOYS RESTROOM
A108	CLASSROOM
A108A	GIRLS RESTROOM
A108B	BOYS RESTROOM
A109	ART ROOM
A110	KILN ROOM

A111	ART STORAGE
A112	CORRIDOR
A113	MUSIC ROOM
A114	RESTROOM
A115	FAMILY RESTROOM
A116	CLASSROOM
A116A	GIRLS RESTROOM
A116B	BOYS RESTROOM
A117	CORRIDOR
A118	CLASSROOM
A118A	GIRLS RESTROOM
A118B	BOYS RESTROOM
A119	CLASSROOM
A119A	GIRLS RESTROOM
A119B	BOYS RESTROOM
A120	CLASSROOM
A120A	GIRLS RESTROOM
A120B	BOYS RESTROOM
A121	CLASSROOM
A121A	GIRLS RESTROOM
A121B	BOYS RESTROOM
A122	CLASSROOM
A122A	GIRLS RESTROOM
A122B	BOYS RESTROOM

ALTERNATE SUMMARY	
ALTERNATE #	ALTERNATE DESCRIPTION
1	NEW HAVEN: REPLACE CEILING GRID AND PADS, PROVIDE LED LIGHTS, PROVIDE OCCUPANCY SENSORS, PROVIDE DIMMING AND CONTROL.
2	NEW HAVEN: REPLACE CEILING GRID AND PADS, PROVIDE LED LIGHTS, PROVIDE OCCUPANCY SENSORS, PROVIDE DIMMING AND CONTROL.
3	NEW HAVEN: REPLACE CEILING GRID AND PADS, PROVIDE LED LIGHTS, PROVIDE OCCUPANCY SENSORS, PROVIDE DIMMING AND CONTROL.
4	LEO: REPLACE CEILING GRID AND PADS WHERE INDICATED ON ARCHITECTURAL SHEETS.
5	NEW HAVEN & LEO: REPLACE EXIT SIGNS AND EMERGENCY LIGHTS AS INDICATED ON LIGHTING SHEET.
**	IF CEILING ALTERNATES ARE ACCEPTED THE GENERAL CONTRACTOR SHALL APPLY FOR PERMITS AT ALLEN COUNTY BUILDING DEPARTMENT


KEYNOTE SCHEDULE	
#	KEYNOTE DESCRIPTION
1	REMOVE EXISTING CURTAIN TRACK AND REINSTALL ONTO NEW CEILING GRID.
2	CUT CEILING TILE AROUND DUCT WORK

REFLECTED CEILING PLAN LEGEND


- CEILING DEMOLITION DESIGNATION
- KEYNOTE DESIGNATION - REFERENCE KEYNOTE SCHEDULE.
- ROOM DESIGNATION - REFERENCE ROOM INDEX.

REFERENCE ELECTRICAL DRAWINGS
FOR ADDITIONAL INFORMATION:

- SOUND SYSTEM CEILING SPEAKER.
- FIRE ALARM SMOKE OR HEAT DETECTOR.
- WIRELESS ACCESS POINT (WAP).
- INTERIOR DOME CAMERA - CEILING / WALL MOUNTED.
- CEILING MOUNT PROJECTOR & MOUNT.
- LIGHT FIXTURE.
- LIGHT FIXTURE.
- LIGHT FIXTURE.
- CEILING-MOUNTED EXIT SIGN.
- OCCUPANCY SENSOR.
- AIR TERMINAL.
- AIR TERMINAL.
- EXHAUST FAN
- CABINET HEATER

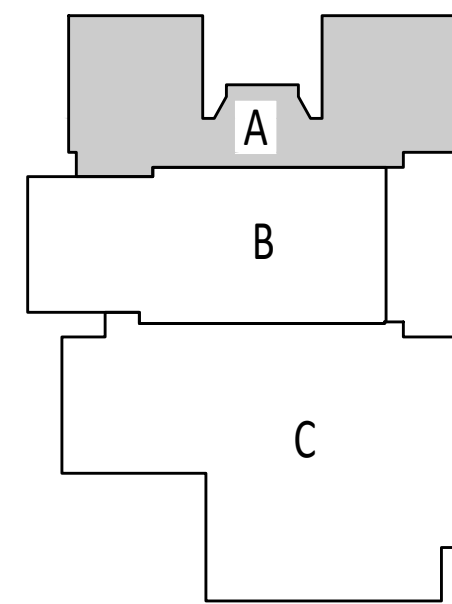

KEY PLAN

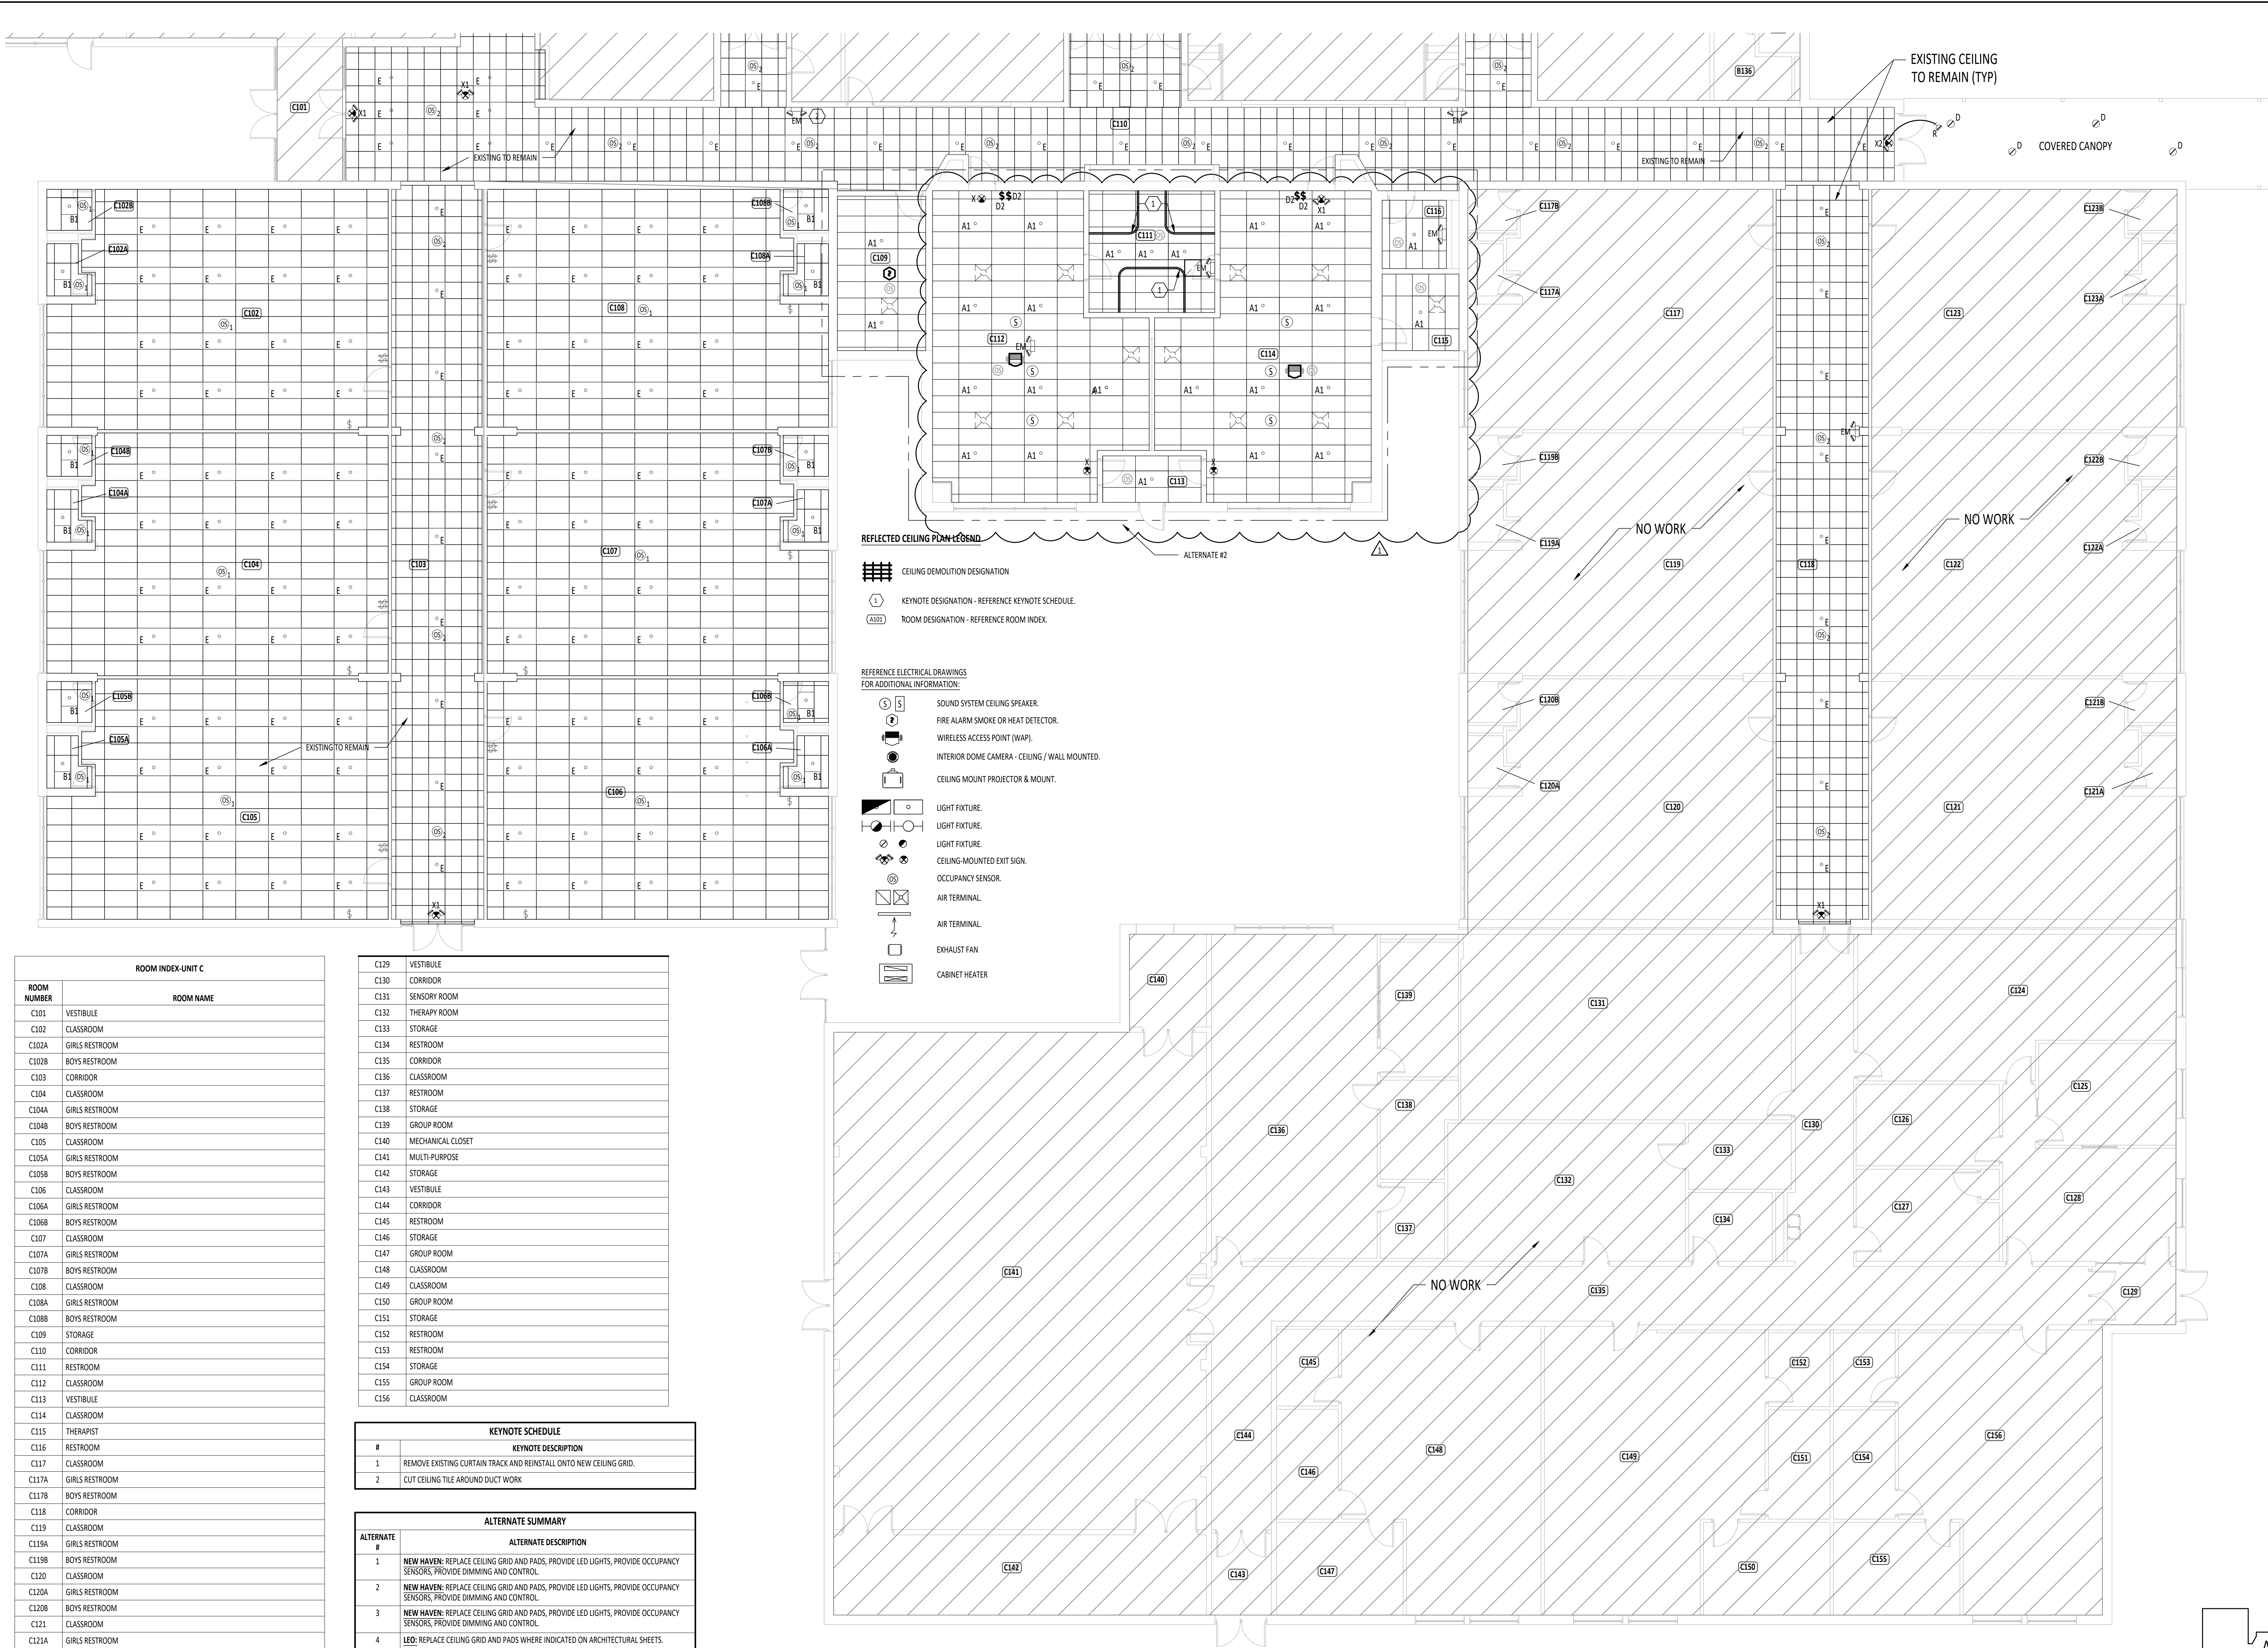


ROOM INDEX-UNIT C	
ROOM NUMBER	ROOM NAME
C101	VESTIBULE
C102	CLASSROOM
C102A	GIRLS RESTROOM
C102B	BOYS RESTROOM
C103	CORRIDOR
C104	CLASSROOM
C104A	GIRLS RESTROOM
C104B	BOYS RESTROOM
C105	CLASSROOM
C105A	GIRLS RESTROOM
C105B	BOYS RESTROOM
C106	CLASSROOM
C106A	GIRLS RESTROOM
C106B	BOYS RESTROOM
C107	CLASSROOM
C107A	GIRLS RESTROOM
C107B	BOYS RESTROOM
C108	CLASSROOM
C108A	GIRLS RESTROOM
C108B	BOYS RESTROOM
C109	STORAGE
C110	CORRIDOR
C111	RESTROOM
C112	CLASSROOM
C113	VESTIBULE
C114	CLASSROOM
C115	THERAPIST
C116	RESTROOM
C117	CLASSROOM
C117A	GIRLS RESTROOM
C117B	BOYS RESTROOM
C118	CORRIDOR
C119	CLASSROOM
C119A	GIRLS RESTROOM
C119B	BOYS RESTROOM
C120	CLASSROOM
C120A	GIRLS RESTROOM
C120B	BOYS RESTROOM
C121	CLASSROOM
C121A	GIRLS RESTROOM
C121B	BOYS RESTROOM
C122	CLASSROOM
C122A	GIRLS RESTROOM
C122B	BOYS RESTROOM
C123	CLASSROOM
C123A	GIRLS RESTROOM
C123B	BOYS RESTROOM
C124	BREAK/WORKROOM
C125	OFFICE
C126	CONFERENCE ROOM
C127	OFFICE
C128	RECEPTION AREA

C129	VESTIBULE
C130	CORRIDOR
C131	SENSORY ROOM
C132	THERAPY ROOM
C133	STORAGE
C134	RESTROOM
C135	CORRIDOR
C136	CLASSROOM
C137	RESTROOM
C138	STORAGE
C139	GROUP ROOM
C140	MECHANICAL CLOSET
C141	MULTI-PURPOSE
C142	STORAGE
C143	VESTIBULE
C144	CORRIDOR
C145	RESTROOM
C146	STORAGE
C147	GROUP ROOM
C148	CLASSROOM
C149	CLASSROOM
C150	GROUP ROOM
C151	STORAGE
C152	RESTROOM
C153	RESTROOM
C154	STORAGE
C155	GROUP ROOM
C156	CLASSROOM

KEYNOTE SCHEDULE	
#	KEYNOTE DESCRIPTION
1	REMOVE EXISTING CURTAIN TRACK AND REINSTALL ONTO NEW CEILING GRID.
2	CUT CEILING TILE AROUND DUCT WORK

ALTERNATE SUMMARY	
ALTERNATE #	ALTERNATE DESCRIPTION
1	NEW HAVEN: REPLACE CEILING GRID AND PADS, PROVIDE LED LIGHTS, PROVIDE OCCUPANCY SENSORS, PROVIDE DIMMING AND CONTROL.
2	NEW HAVEN: REPLACE CEILING GRID AND PADS, PROVIDE LED LIGHTS, PROVIDE OCCUPANCY SENSORS, PROVIDE DIMMING AND CONTROL.
3	NEW HAVEN: REPLACE CEILING GRID AND PADS, PROVIDE LED LIGHTS, PROVIDE OCCUPANCY SENSORS, PROVIDE DIMMING AND CONTROL.
4	LED: REPLACE CEILING GRID AND PADS WHERE INDICATED ON ARCHITECTURAL SHEETS.
5	NEW HAVEN & LED: REPLACE EXIT SIGNS AND EMERGENCY LIGHTS AS INDICATED ON LIGHTING SHEET.
**	IF CEILING ALTERNATES ARE ACCEPTED THE GENERAL CONTRACTOR SHALL APPLY FOR PERMITS AT ALLEN COUNTY BUILDING DEPARTMENT

- REFLECTED CEILING PLAN - SECOND**
- CEILING DEMOLITION DESIGNATION**
- KEYNOTE DESIGNATION - REFERENCE KEYNOTE SCHEDULE.**
- ROOM DESIGNATION - REFERENCE ROOM INDEX.**
- REFERENCE ELECTRICAL DRAWINGS FOR ADDITIONAL INFORMATION:**
- SOUND SYSTEM CEILING SPEAKER.
 - FIRE ALARM SMOKE OR HEAT DETECTOR.
 - WIRELESS ACCESS POINT (WAP).
 - INTERIOR DOME CAMERA - CEILING / WALL MOUNTED.
 - CEILING MOUNT PROJECTOR & MOUNT.
 - LIGHT FIXTURE.
 - LIGHT FIXTURE.
 - LIGHT FIXTURE.
 - CEILING MOUNTED EXIT SIGN.
 - OCCUPANCY SENSOR.
 - AIR TERMINAL.
 - AIR TERMINAL.
 - EXHAUST FAN.
 - CABINET HEATER.

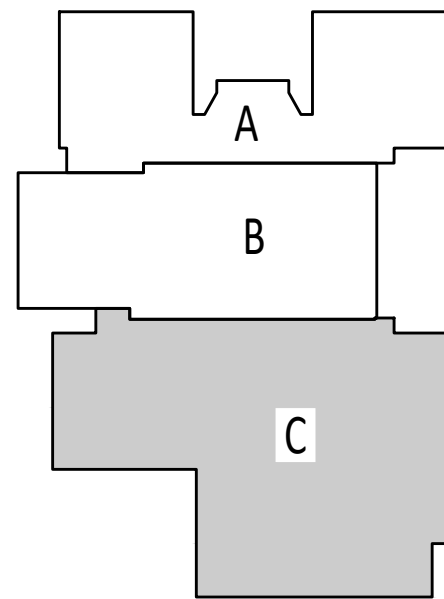

KEY PLAN



ISSUANCES/REVISIONS		
BID DOCUMENTS	02/07/2024	
ADDENDUM #2	02/23/2024	
1		

PROJECT NUMBER:	DRAWN BY:	CHECKED BY:
23085.00	RLS	KCR

SHEET TITLE:	
NEW HAVEN - FIRST FLOOR REFLECTED CEILING PLAN - UNIT C	

SHEET NUMBER:
A2.3